

DIMENSIONS in mm

REVISIONS:				COPYRIGHT	
				THIS DRAWING IS COPYRIGHT AND THE PROPERTY OF THE AUTHOR IT MUST NOT BE RETAINED, COPIED OR USED WITHOUT THE AUTHORITY OF THE AUTHOR.	
				DISCLAIMER	
				THIS DRAWING AND ITS CONTENTS ARE ELECTRONICALLY GENERATED, ARE CONFIDENTIAL AND MAY ONLY BE USED FOR THE PURPOSE FOR WHICH THEY WERE INTENDED. THE AUTHOR WILL NOT ACCEPT RESPONSIBILITY FOR ANY CONSEQUENCES ARISING FROM THE USE OF THIS DRAWING FOR OTHER THAN ITS INTENDED PURPOSE OR WHERE THE DRAWING HAS BEEN ALTERED, AMENDED OR CHANGED EITHER MANUALLY OR ELECTRONICALLY BY ANY THIRD PARTY.	
				NOTE	
				THIS IS AN UNCONTROLLED DOCUMENT ISSUED FOR INFORMATION PURPOSES ONLY, UNLESS THE CHECKED SECTIONS ARE SIGNED OR COMPLETED. FIGURED DIMENSIONS TAKE PRECEDENCE OVER SCALED. DO NOT SCALE REDUCED SIZE DRAWINGS. VERIFY DIMENSIONS PRIOR TO COMMENCING ANY QUOTE OR OFF-SITE WORK. FOR FURTHER INFORMATION, PLEASE ASK	
B	REVISED		DDC	18/12/24	
A	ISSUED FOR APPROVAL	REVISION DESCRIPTION	DDC	17/12/24	

**COPYRIGHT**  
THIS DRAWING IS COPYRIGHT AND THE PROPERTY OF THE AUTHOR IT MUST NOT BE RETAINED, COPIED OR USED WITHOUT THE AUTHORITY OF THE AUTHOR.

**DISCLAIMER**  
THIS DRAWING AND ITS CONTENTS ARE ELECTRONICALLY GENERATED, ARE CONFIDENTIAL AND MAY ONLY BE USED FOR THE PURPOSE FOR WHICH THEY WERE INTENDED. THE AUTHOR WILL ACCEPT NO RESPONSIBILITY FOR ANY CONSEQUENCES ARISING FROM THE USE OF THE DRAWING FOR OTHER THAN ITS INTENDED PURPOSE OR WHERE THE DRAWING HAS BEEN ALTERED, AMENDED OR CHANGED EITHER MANUALLY OR ELECTRONICALLY BY ANY THIRD PARTY.

**NOTE**  
THIS IS AN UNCONTROLLED DOCUMENT ISSUED FOR INFORMATION PURPOSES ONLY. UNLESS THE CHECKED SECTIONS ARE SIGNED OR COMPLETED: FIGURED DIMENSIONS TAKE PRECEDENCE OVER SCALED; DO NOT SCALE REDUCED SIZE DRAWINGS. VERY DIMENSIONS PRIOR TO COMMENTING ANY ON SITE OR OFF-SITE WORKS OR FABRICATION. IF IN DOUBT, ASK

**HLS**  
Equipment



PROJECT TITLE

DRAWING TITLE  
HLS - TAV - DL4F - 01

PROJECT LEADER:	1. GILBERT
-----------------	------------

A. SHARPE

DESIGNER:

DRAFTSPERSON:  
MMM

	MMI
	SCALE:



SIGNATURE: \_\_\_\_\_

DATE: NOVEM


SHEET SIZE:

---

A3

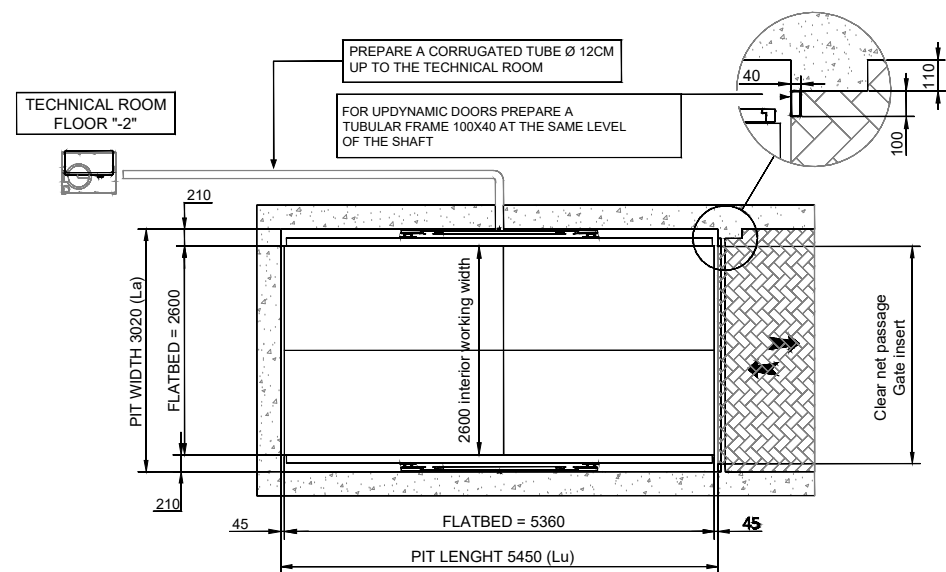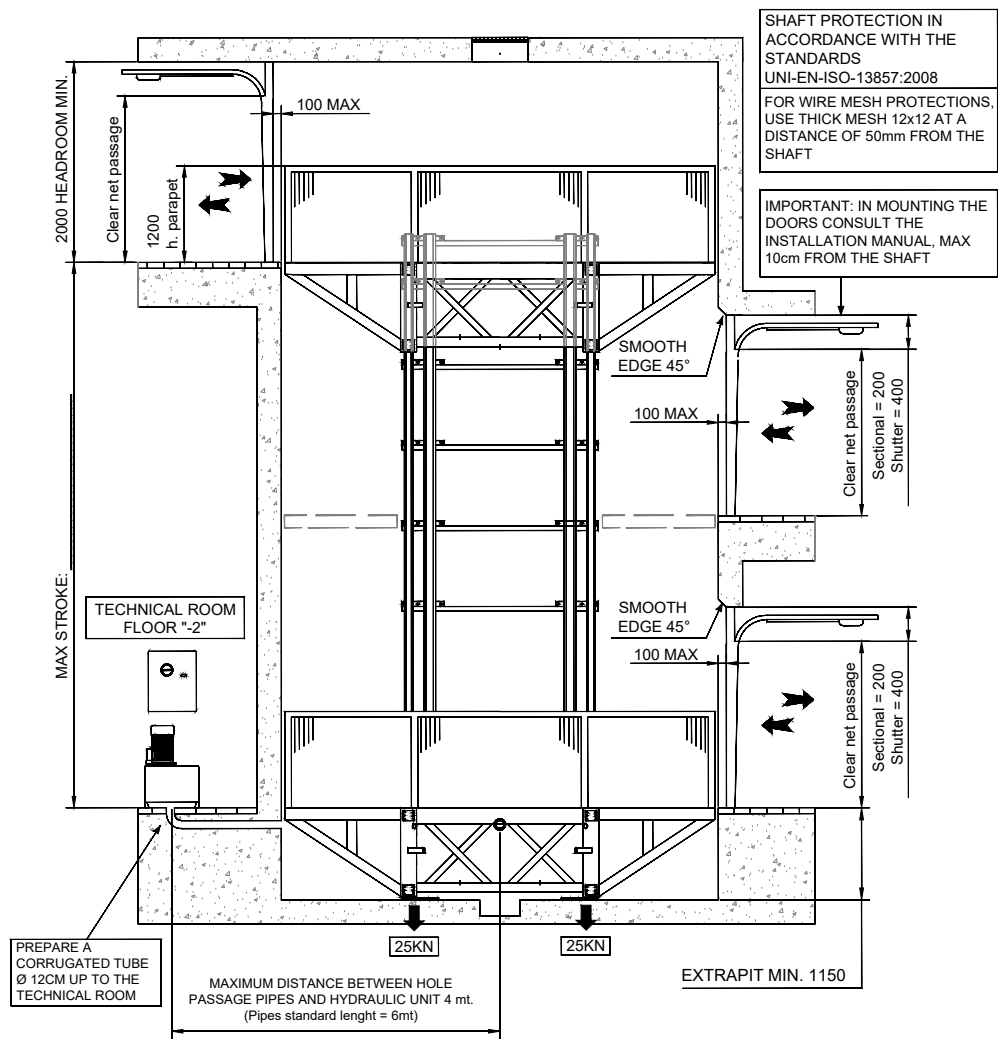


GOODSLIFT DL4

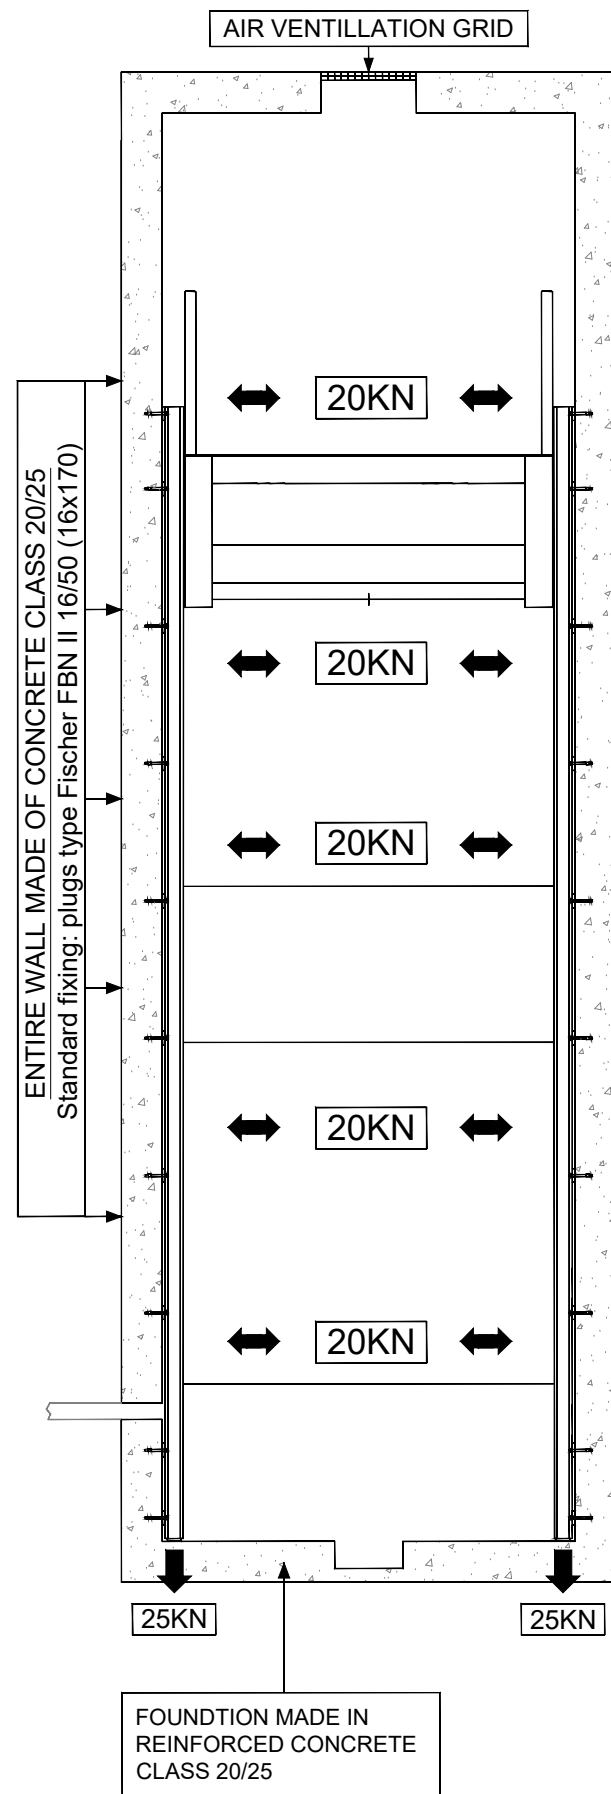

PIT DRAWINGS

MARK WITH AN "x" THE ACCESS TO THE FLOORS AND THE HEIGHT OF THE INTERFLOORS

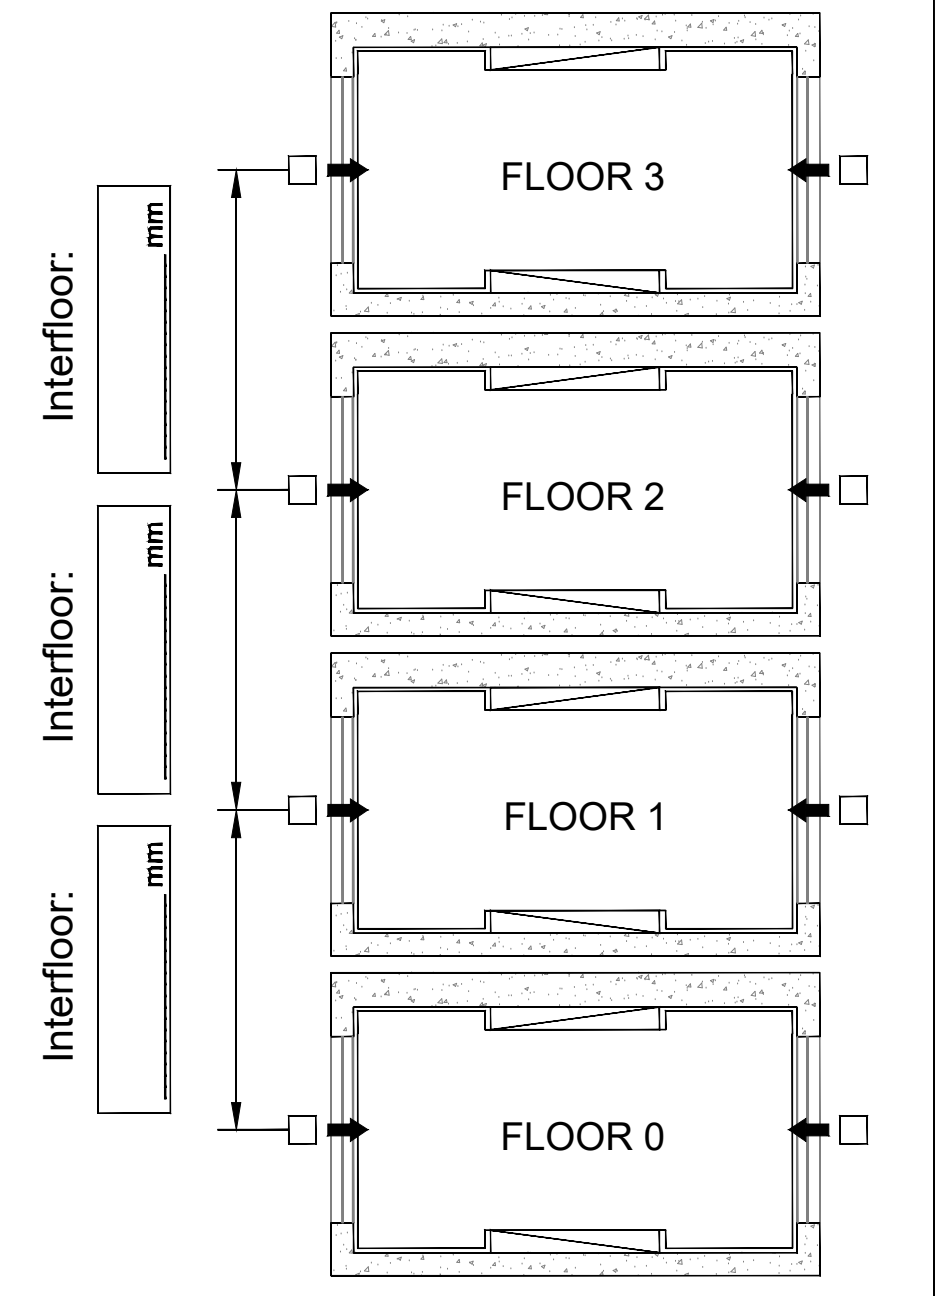

PREPARE A LINE PH+N+T (GND) or 3PH+N+E ,PROVIDE AUTOMATIC MAGNETOTHERMIC BREAKER CURVE "C" WITH DIFFERENTIAL , Id = 0.3A

Motor	Tension-functioning	Speed CM / sec	Starter	Suggested switch*	Rated current	Current starter
5,5kW	380 V - 3Ph	8,4	Direct	4x16A id=0,3A	11	35
7,5kW	380 V - 3Ph	10,5	Direct	4x16A id=0,3A	14,5	45
9,2kW	380 V - 3Ph	12,4	Direct	4x20A id=0,3A	18	56

NOTE: ANY REDUCTION OF THE SPACE BETWEEN THE PLATFORM AND THE THRESHOLD IS AT THE EXPENCE OF THE CUSTOMER, ANY COMPENSATION MUST INCLUDE A SMOOTH EDGE OF 45° INSIDE THE SHAFT

IMPORTANT: IN MOUNTING THE DOORS CONSULT THE INSTALLATION MANUAL, MAX 10cm FROM THE SHAFT

DIMENSIONS in mm

REVISIONS:		COPYRIGHT	
		THIS DRAWING IS COPYRIGHT AND THE PROPERTY OF THE AUTHOR IT MUST NOT BE RETAINED, COPIED OR USED WITHOUT THE AUTHORITY OF THE AUTHOR.	
		DISCLAIMER	
		THIS DRAWING AND ITS CONTENTS ARE ELECTRONICALLY GENERATED, ARE CONFIDENTIAL AND MAY ONLY BE USED FOR THE PURPOSE FOR WHICH THEY WERE INTENDED. THE AUTHOR WILL NOT ACCEPT RESPONSIBILITY FOR ANY CONSEQUENCES ARISING FROM THE USE OF THE DRAWING FOR OTHER THAN ITS INTENDED PURPOSE OR WHERE THE DRAWING HAS BEEN ALTERED, AMENDED OR CHANGED EITHER MANUALLY OR ELECTRONICALLY BY ANY THIRD PARTY.	
		NOTE	
		THIS IS AN UNCONTROLLED DOCUMENT ISSUED FOR INFORMATION PURPOSES ONLY, UNLESS THE CHECKED SECTIONS ARE SIGNED OR COMPLETED. FIGURED DIMENSIONS TAKE PRECEDENCE OVER SCALED. DO NOT SCALE REDUCED SIZE DRAWINGS. VERIFY DIMENSIONS PRIOR TO COMMENCING ANY ON-SITE OR OFF-SITE WORKS OR FABRICATION. IF IN DOUBT - ASK.	
No.	REVISION DESCRIPTION	DRAWN	DATE
B	REVISED	DDC	18/12/24
A	ISSUED FOR APPROVAL	DDC	17/12/24

HLS  
Equipment



PROJECT TITLE		PROJECT LEADER		SIGNATURE:	
		A.SHARPE			
		DESIGNER:			
		DRAFTSPERSON:		DATE:	
		MM		NOVEMBER 2025	
		SCALE:		SHEET SIZE:	
		NOT TO SCALE		A3	
		JOB No.:		DRAWING No.:	
				REVISION:	
				B	